


1. THIS DRAWING IS TO BE READ IN CONJUNCTION WITH ALL RELEVANT ARCHITECTS AND ENGINEERS DRAWING INFORMATION.
2. ANY DISCREPANCIES NOTED BETWEEN ARCHITECTS' AND ENGINEERS' DETAILS REGARDING ANY MATERIALS, FORM OR DIMENSIONS SHALL BE BROUGHT TO THE NOTICE OF THE ARCHITECT AND ENGINEER.

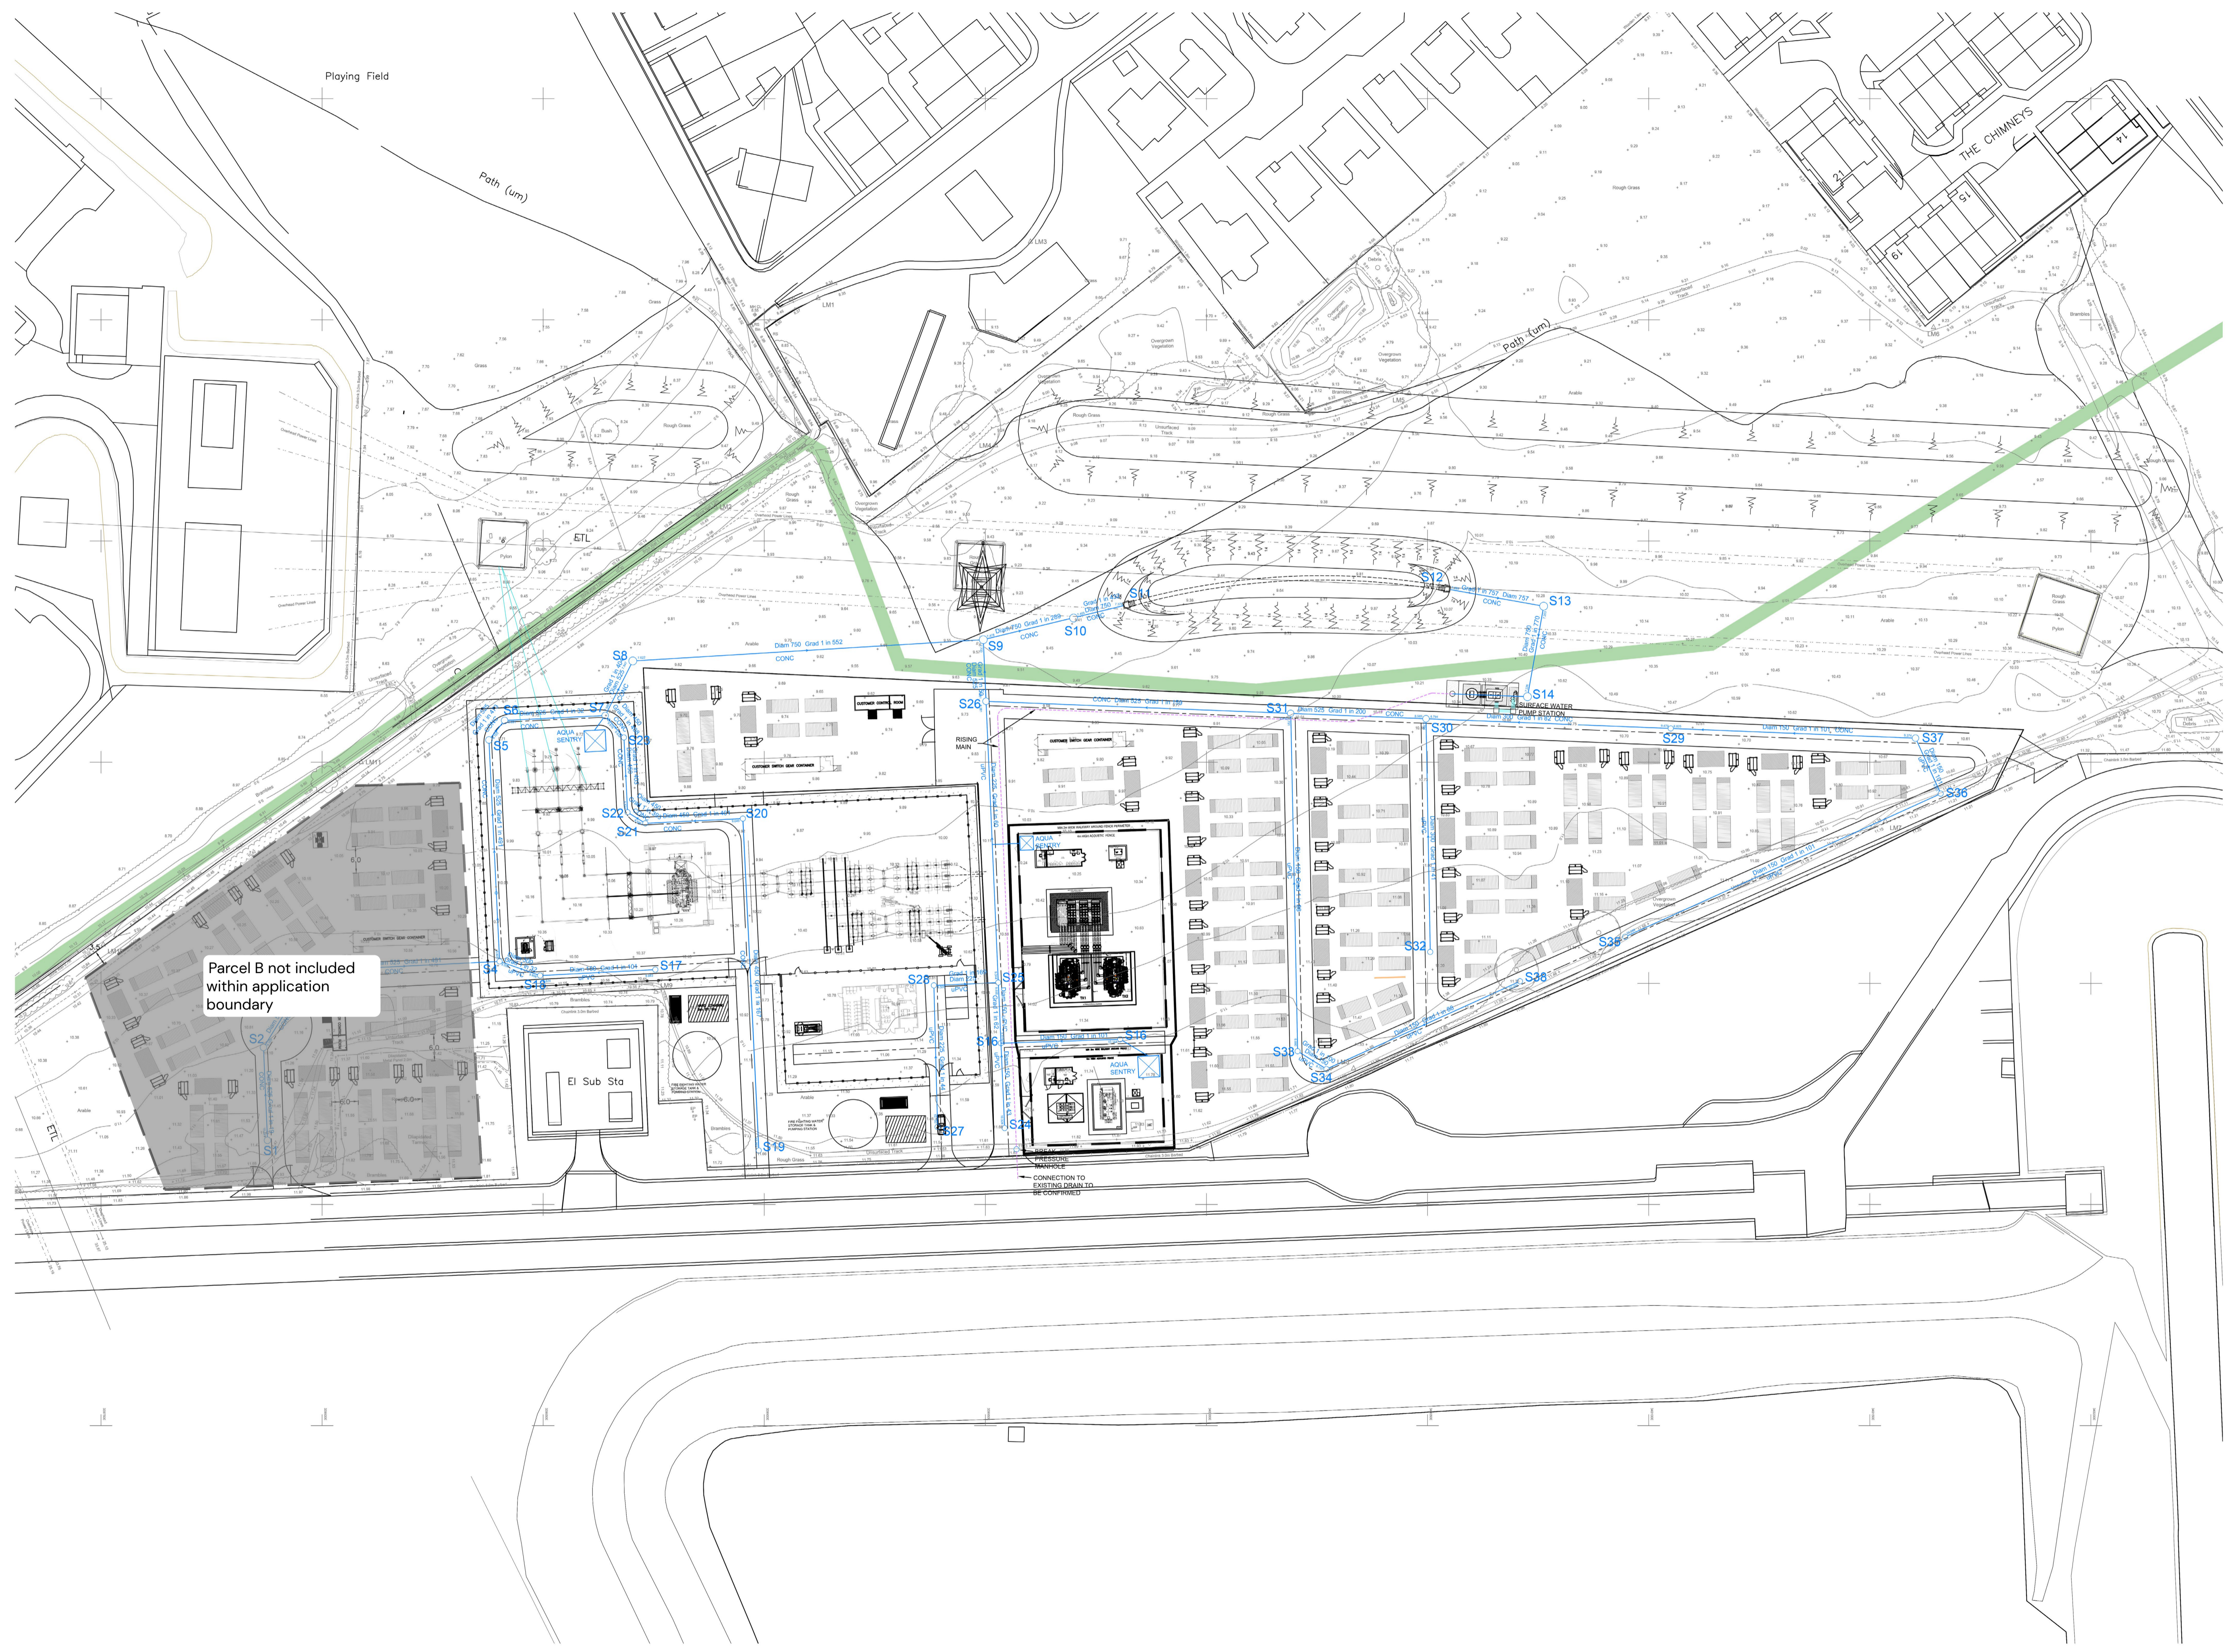

DAVID R. MURRAY and ASSOCIATES  
 125 St. Brides Road, Edinburgh EH12 5HT  
 Tel: 0131 334 0795, Fax: 0131 316 4340  
 E-Mail: dr@davidmurray.co.uk  
 11 Eyre Place, Edinburgh EH1 1SE  
 Tel: 0131 556 5155, Fax: 0131 556 9147  
 E-Mail: dr@davidmurray.co.uk  
 20 Viewfield Terrace, Dunfermline KY12 7JZ  
 Tel: 01383 726075, Fax: 01383 736600  
 E-Mail: dr@davidmurray.co.uk

Client	COCKENZIE STORAGE LTD
Project	PROPOSED SITE AT COCKENZIE
Title	DRAINAGE LAYOUT

Scale	Drawn	chkd	Appd	Date	21/07/2023	18/08/2024	18/08/2024	Drawing No.	E12843/2002	Rev.	
-------	-------	------	------	------	------------	------------	------------	-------------	-------------	------	--